

Ground floor plan
Lighting System Layout

Design	Checked	Drawn	Original Scale	Date	Site	Rev
				16-11-2023	A3	
					A3	
					Rev	0

Drawing Number
E00

Project:
BUS TERMINAL REHABILITATION
PROJECT / KARAK



Designed By :

PLOT NO.	
BUSM. NO.	
LOCATION :	

Purpose of Issue

Rev

Date

Authorized

Rev


Description

Drawn

Checked

Authorized

KEY PLAN

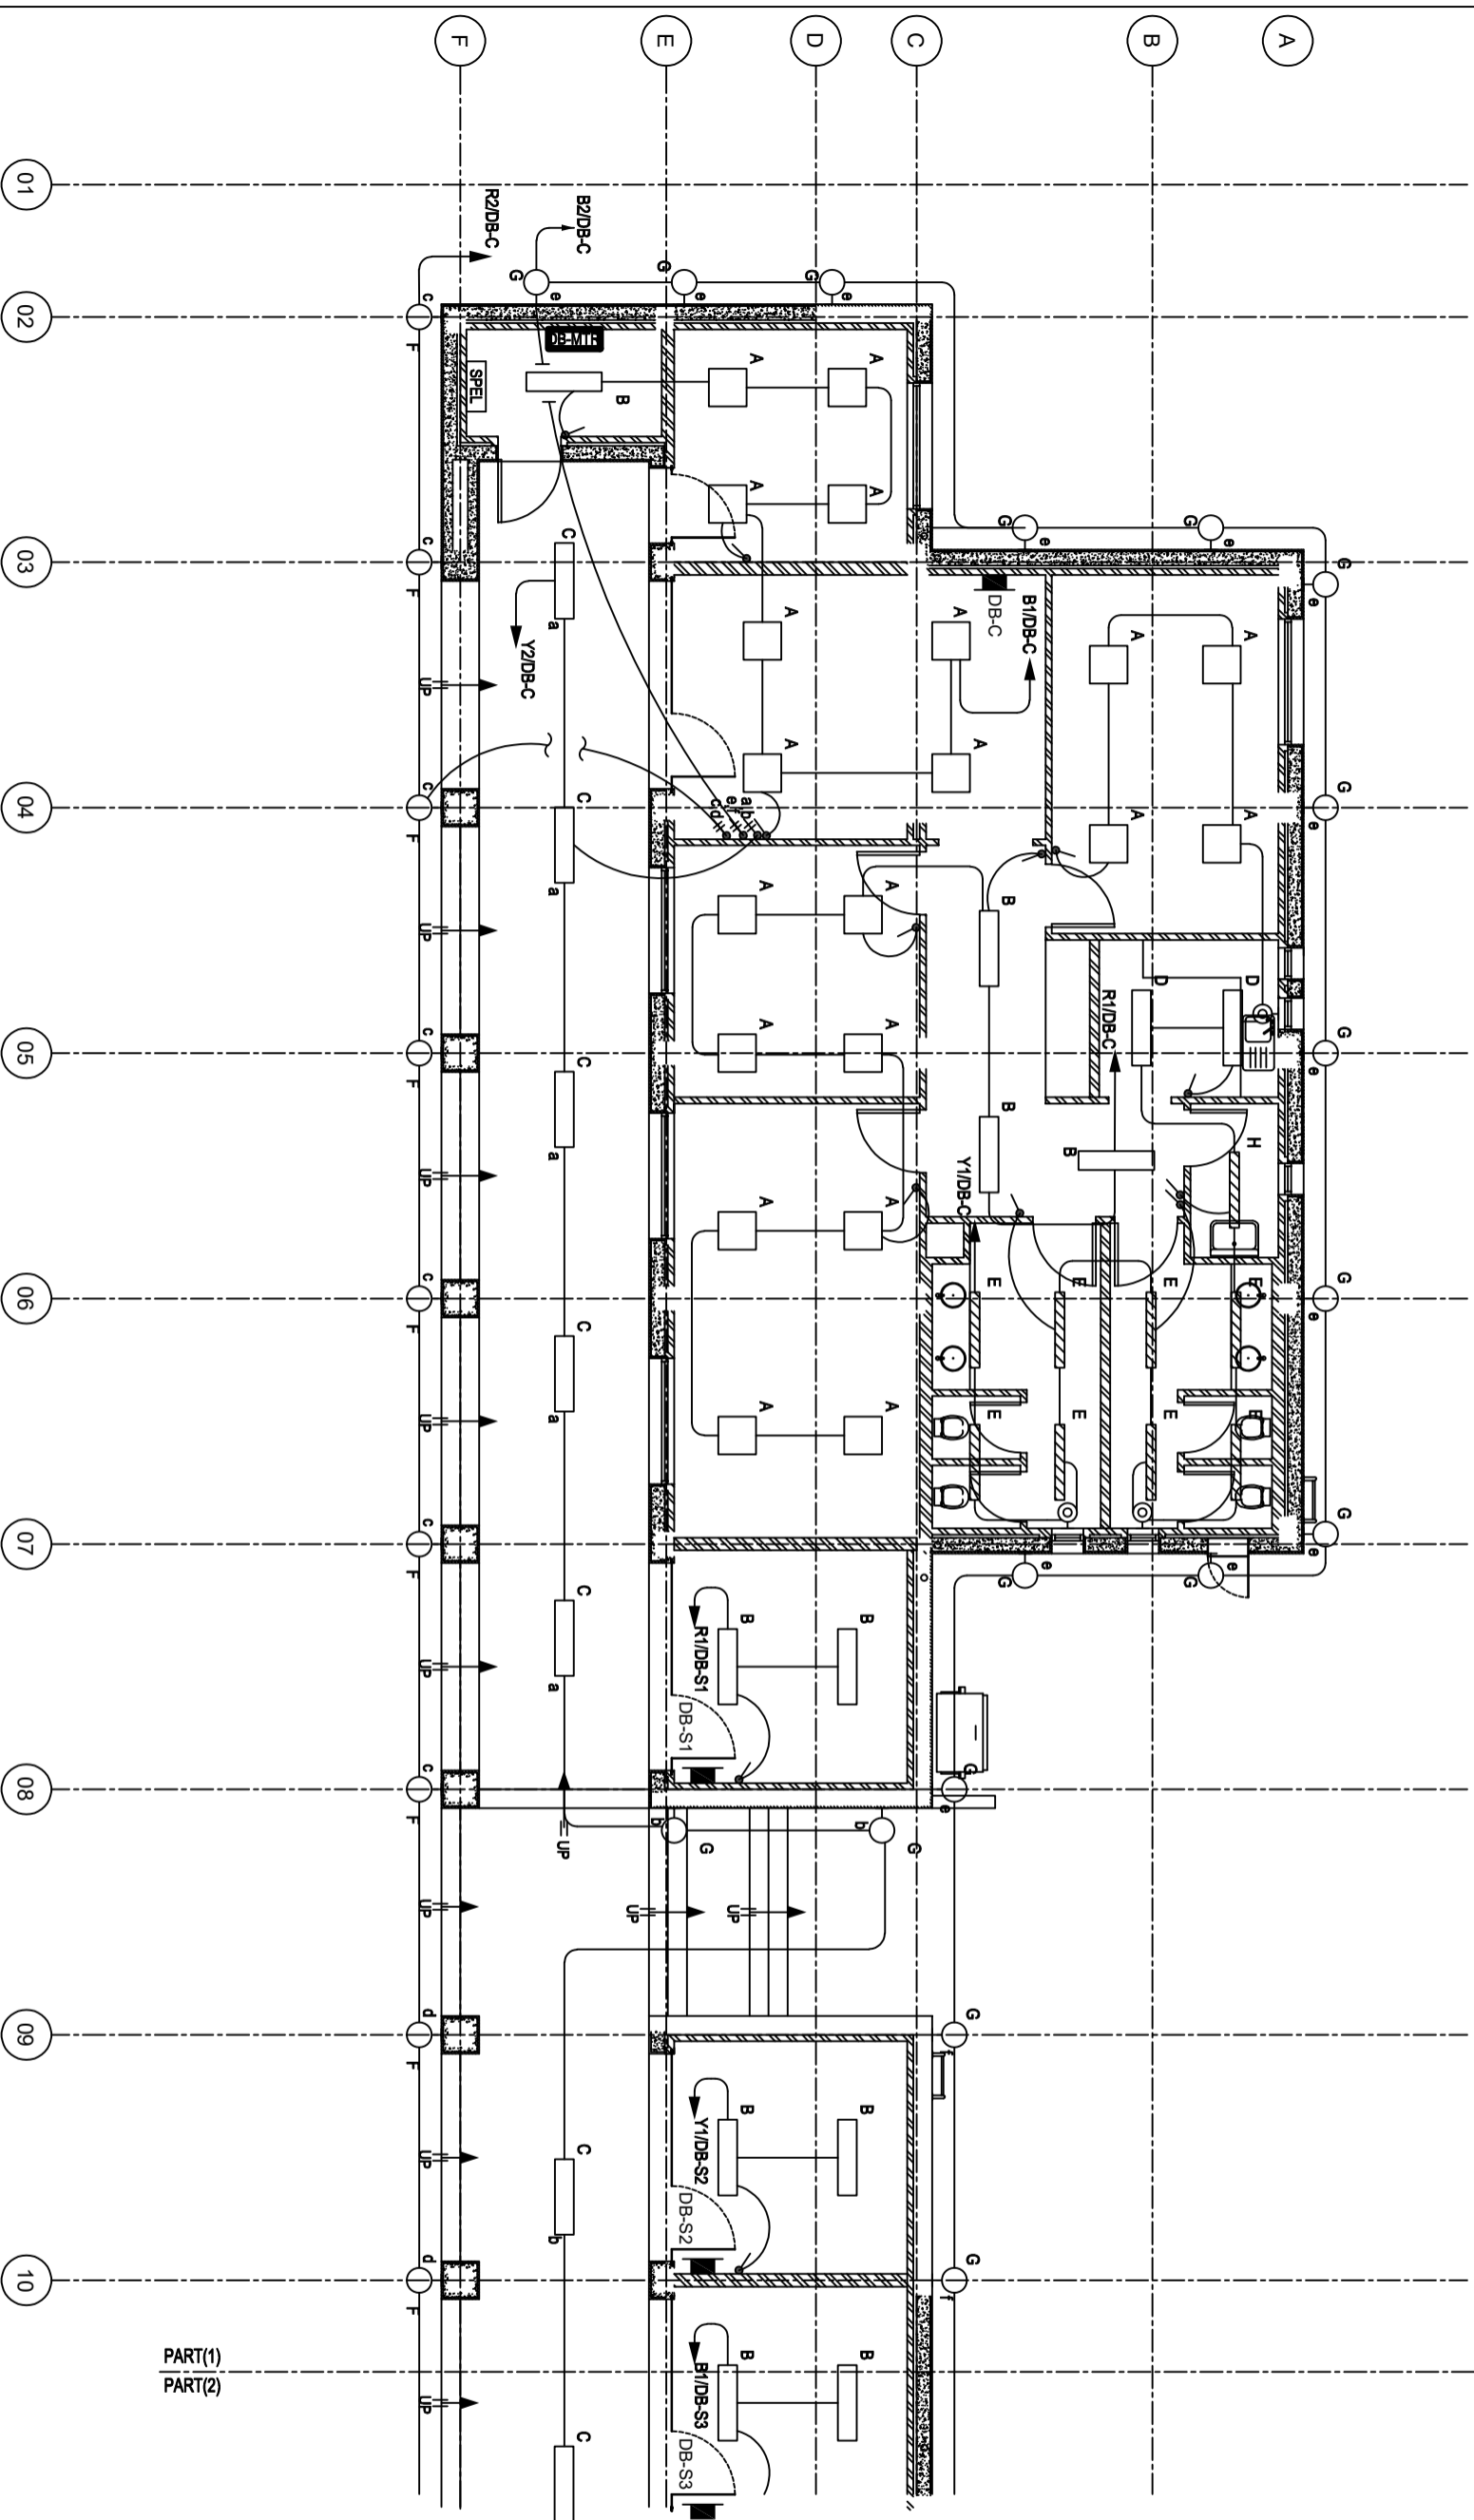

PART(1) PART(2) MATCH LINE 1

KEY PLAN

Rev	Description	Drawn	Checked	Authorised

Purpose of issue

Rev	Date	Authorised

PLOT NO.
BASIN NO.
LOCATION :

designed by :

PROJECTS DIVISION
LAND TRANSPORT
TERMINALS DEPARTMENT

Project:
**BUS TERMINAL REHABILITATION
PROJECT / KARAK**

Drawing title:
**Ground floor plan
Lighting System Layout
PART1/3**

Design			
Checked			
Drawn			
Original Scale			
Date:	16-11-2023	Size	A3
Drawing Number	E01	Rev	0

قسم المشاريع - مراقف النقل